



COPYRIGHT 2016 STEELE ASSOCIATES ARCHITECTS, L.L.C.
All rights reserved. Reproduction or use in any form or by any means (graphic, electronic, mechanical, etc.) without written permission of STEELE ASSOCIATES ARCHITECTS, L.L.C. is unlawful and subject to criminal prosecution.



STEEL ASSOCIATES
ARCHITECTS LLC
686 NW YORK DRIVE #150
541.382.9867

BEND, OR 97703
info@steele-arch.com
FAX 541.385.8816

KEYNOTES


- 1. 0'-6" x 4'-0" CEILING HUNG LED LIGHT FIXTURE - SEE ELECTRICAL DRAWINGS
- 2. RADIANT HEATER - SEE MECHANICAL DRAWINGS
- 3. EXISTING VEHICLE EXHAUST FAN UNIT
- 4. NEW THROUGH-WALL DUCTING FOR EXISTING VEHICLE EXHAUST FAN UNIT - SEE MECHANICAL DRAWINGS
- 5. NEW VEHICLE EXHAUST FAN UNIT - SEE MECHANICAL DRAWINGS
- 6. EXTENT OF OVERHEAD DOOR TRACK
- 7. PEMB FRAME - SEE PEMB DRAWINGS

GENERAL NOTES


- A. REFER TO GENERAL NOTES ON SHEET G0.01 & PROJECT MANUAL FOR ADDITIONAL INFORMATION
- B. THIS BUILDING TO BE FULLY SPRINKLERED AS PART OF THIS PROJECT. DRY TYPE, SEE SPECIFICATION SECTION 21 000 AND DEFERRED FIRE PROTECTION DRAWINGS
- C. THE REMOVAL AND/OR MODIFICATION OF EXISTING AND/OR PROVISION OF NEW VEHICLE FLUID STORAGE, SUPPLY, & DISPOSAL SYSTEMS AND ALL RELATED COMPONENTS & EQUIPMENT SHALL BE DELEGATED DESIGN AS COORDINATED BY THE OWNER
- D. ELECTRICAL & HVAC FIXTURES ARE SHOWN FOR REFERENCE PURPOSES ONLY - REFER TO ELECTRICAL & MECHANICAL DRAWINGS FOR ADDITIONAL INFORMATION INCLUDING EMERGENCY LIGHTING
- E. PEMB COMPONENTS MAY BE OMITTED FOR CLARITY - SEE PEMB DRAWINGS

LEGEND

- EXISTING WALLS TO REMAIN
- NEW WALLS
- CEILING MOUNTED 0'-6" x 4'-0" LED LIGHT FIXTURE
- RADIANT HEATER

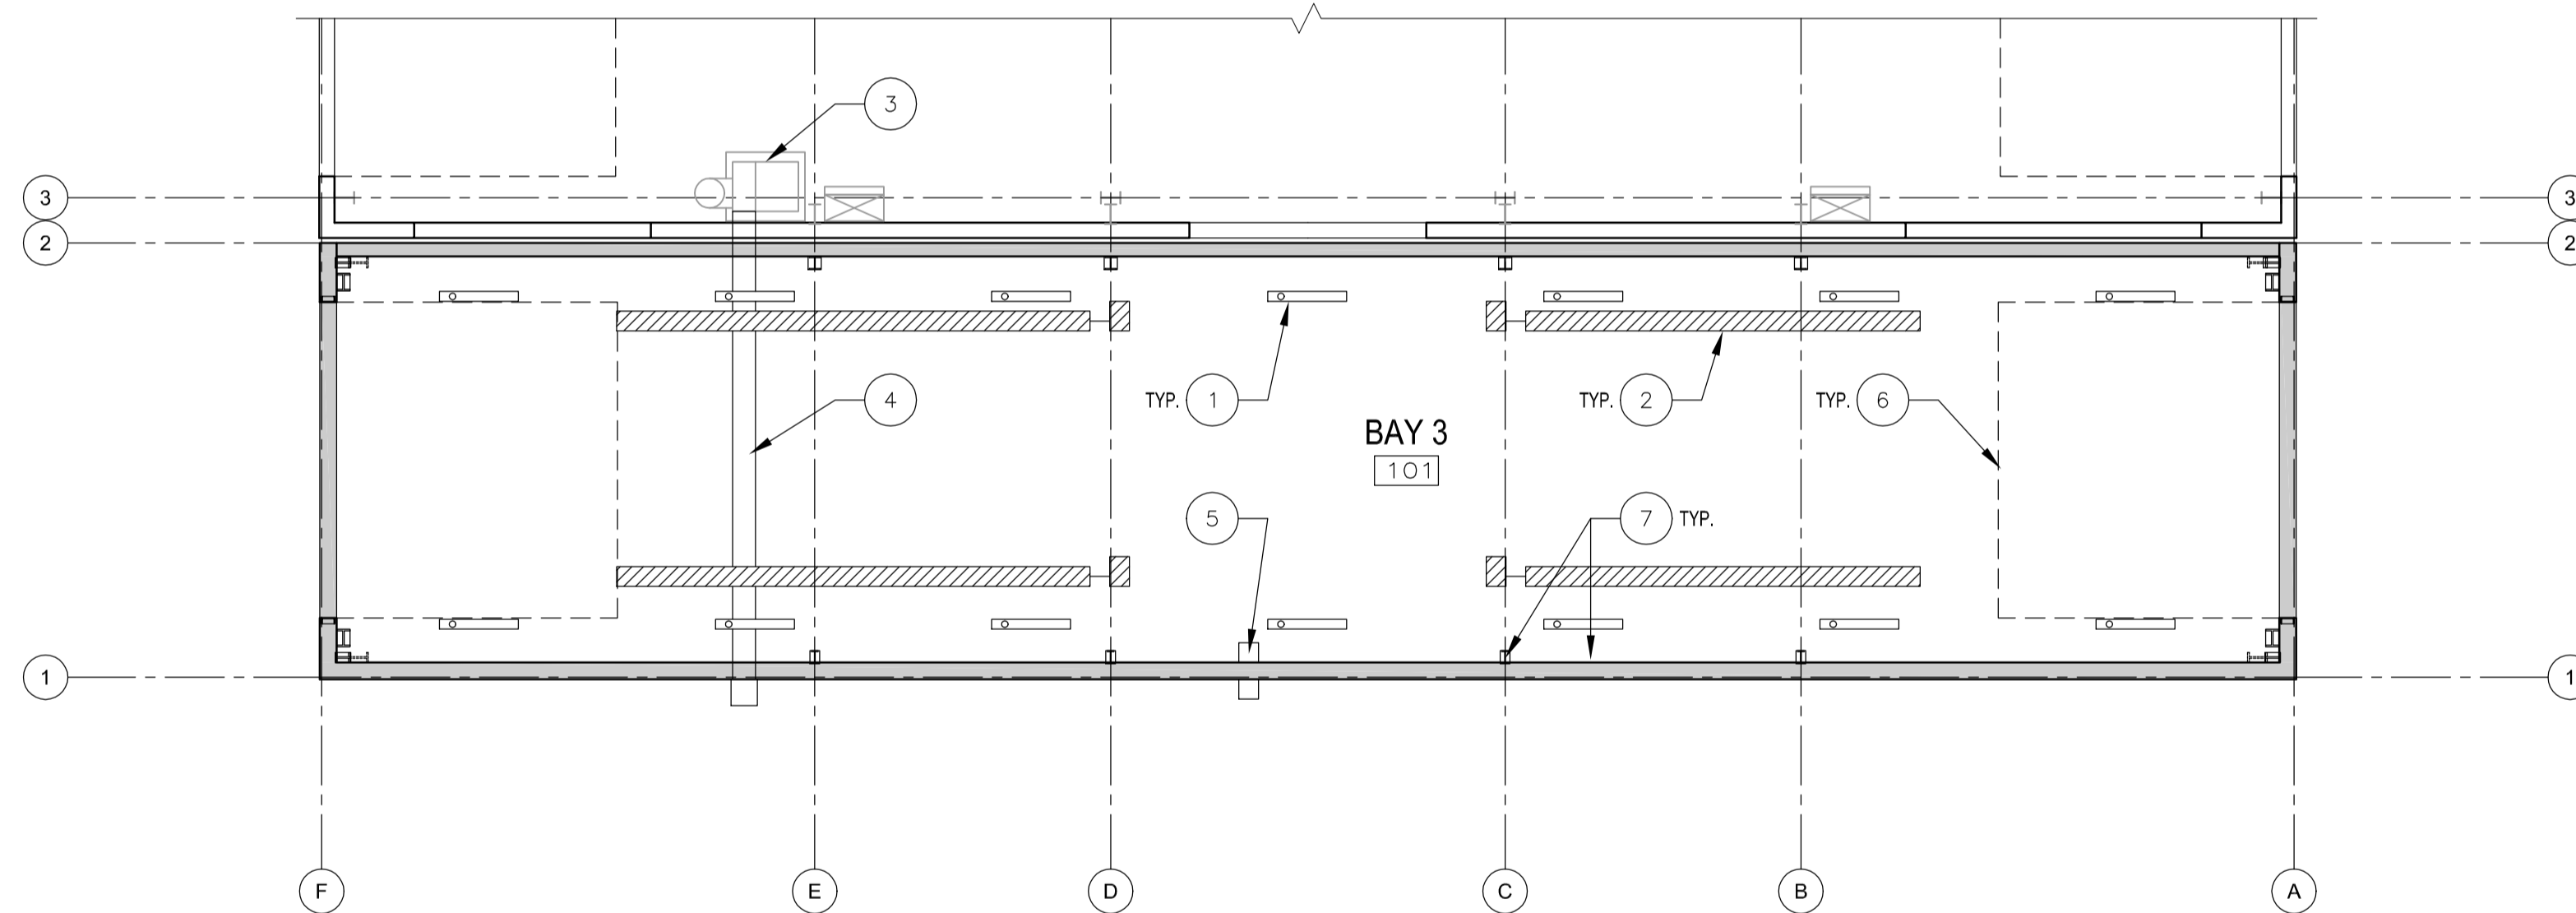

1 SHOP BUILDING REFLECTED CEILING PLAN

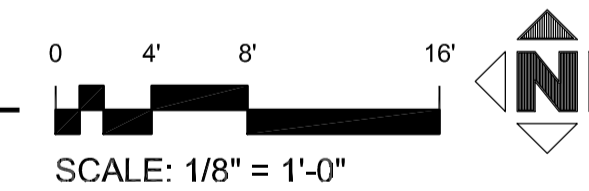

BLS - TRANSPORTATION FACILITY 2017
501 SE 2ND STREET BEND, OR.

SHOP BUILDING REFLECTED CEILING PLAN

JOB NO.	16116.01
DATE	7/7/2017
DRAWN BY	AL
CHECKED BY	DAO/SJS
REVISIONS	DATE
PERMIT SUBMITTAL	07/14/2017

SHEET NO.
A1.26

PERMIT REVIEW SET